 


PRELIMINARY

BETHLEHEM LNG FACILITY			
ELECTRICAL			
SITE LIGHTING PLAN			
BETHLEHEM, NORTHHAMPTON COUNTY, PA			
DRAWN BY		JLT	DATE ISSUED
CHECKED BY		MUN	01/08/2018
APPROVED BY		SCALE	
DWG. NO.		E-100	AS SHOWN
		APPROVED BY	
		E-100	
		SHEET	
		1 OF 1	
		REV. NO.	C

DRAWN BY	JLT	DATE ISSUED	01/08/2018	
CHECKED BY	MJN	SCALE	AS SHOWN	
APPROVED BY	APPROVED BY			
DWG. NO.	E-100	SHEET	1 OF 1	REV. NO. C



EASTON ROAD ACCESS SITE LIGHTING PLAN

SCALE: 1" = 30'-0"

DRAWN BY	JLT	DATE ISSUED	03/08/2018		
CHECKED BY	MJN	SCALE	1" = 30'		
APPROVED BY	APPROVED BY				
DWG. NO.	E-100	SHEET	2 OF 4	REV. NO.	B

A	B	C	D	E	F	G	H
---	---	---	---	---	---	---	---



PLANT
NORTH



TRUE
NORTH

CONTINUED ON DRAWING E-100 SHT 2

ACCESS ROAD

SL-17

SL-18

EASTON ROAD

Spot heights (elevation) are indicated by numbers on the grid, ranging from 0.0 to 17.6.

1. PHOTOMETRIC CALCULATIONS ARE REPRESENTED IN FOOTCANDLES.
2. FOR LIGHT FIXTURE SCHEDULE AND DETAILS SEE DRAWING E-100 SHT 1.

SCALE: 1" = 30'-0"


PRELIMINARY

REFERENCE DRAWINGS		REVISIONS						
		B	REVISED ACCESS ROADS, ADDED WALL PACKS	03/16/2018	JLT	MJN		
		A	PRELIMINARY – FOR REVIEW	03/08/2018	JLT	MJN		
DWG. NO.	TITLE	NO.	DESCRIPTION	DATE	BY	CHK	APPR	APPR



THIS DRAWING IS THE PROPERTY OF UGI ENERGY SERVICES, LLC ("UGIES"). IT MAY CONTAIN INFORMATION DESCRIBING TECHNOLOGY OWNED BY UGIES AND DEEMED TO BE COMMERCIAL/CONFIDENTIAL/SENSITIVE. IT IS TO BE USED ONLY IN CONNECTION WITH WORK PERFORMED BY UGIES. REPRODUCTION IN WHOLE OR IN PART FOR ANY PURPOSE OTHER THAN WORK FOR UGIES IS EXPRESSLY FORBIDDEN EXCEPT BY EXPRESS WRITTEN PERMISSION OF UGIES. IT IS TO BE SAFEGUARDED AGAINST BOTH DELIBERATE AND INADVERTENT DISCLOSURE TO ANY THIRD PARTY.

BETHLEHEM LNG FACILITY			
ELECTRICAL			
SITE LIGHTING PLAN			
BETHLEHEM, NORTHHAMPTON COUNTY, PA			
DRAWN BY	JLT	DATE ISSUED	03/08/2018
CHECKED BY	MUN	SCALE	1" = 30'
APPROVED BY	APPROVED BY		
DWG. NO.	E-100	SHEET	3 OF 4
		REV. NO.	B

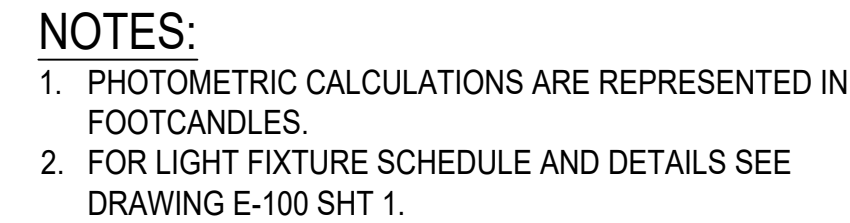

PRELIMINARY

DRAWN BY	JLT	DATE ISSUED	03/08/18
CHECKED BY	MUN	SCALE	1" = 30'
APPROVED BY	APPROVED BY		
DWG. NO.	E-100	SHEET	4 OF 4
			REV. NO. B